




A

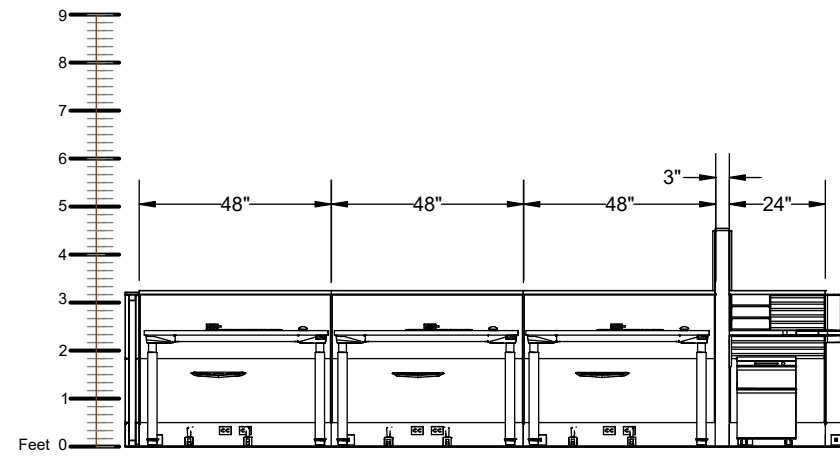


B

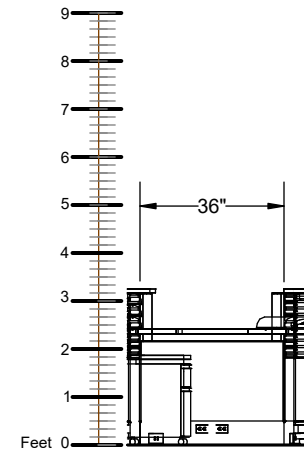


C

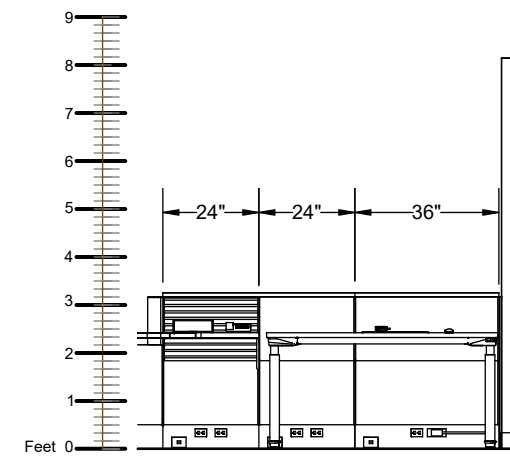


D

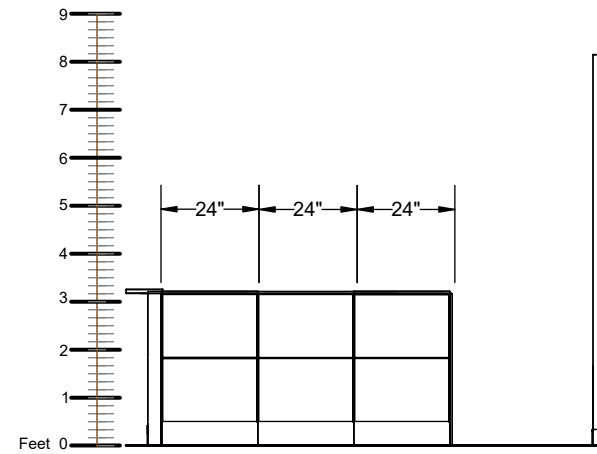


A - 1

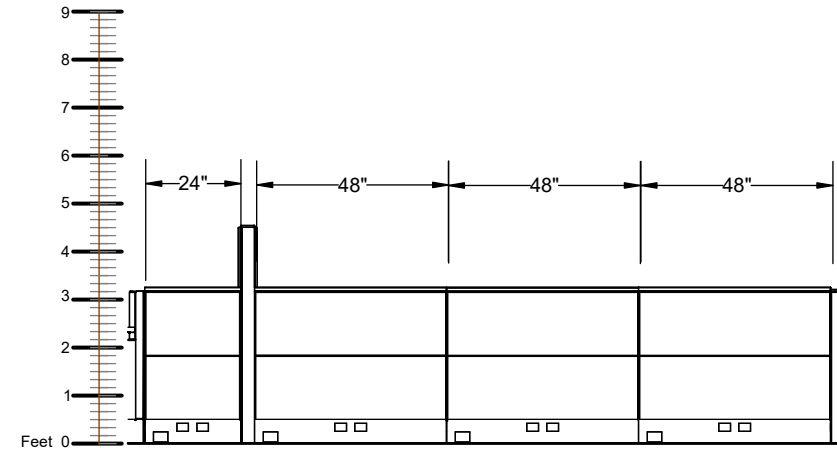

B - 1

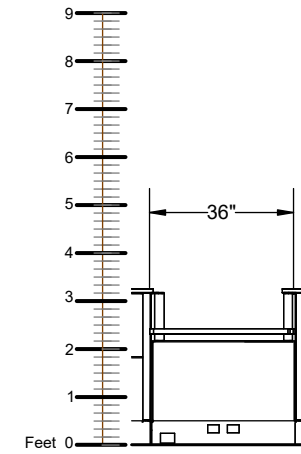


C - 1

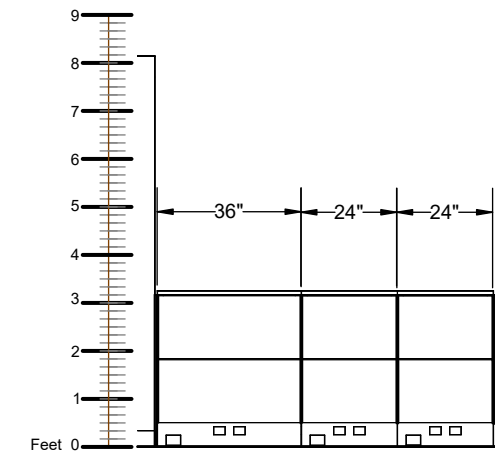


D - 1


Scale 1/4" = 1'

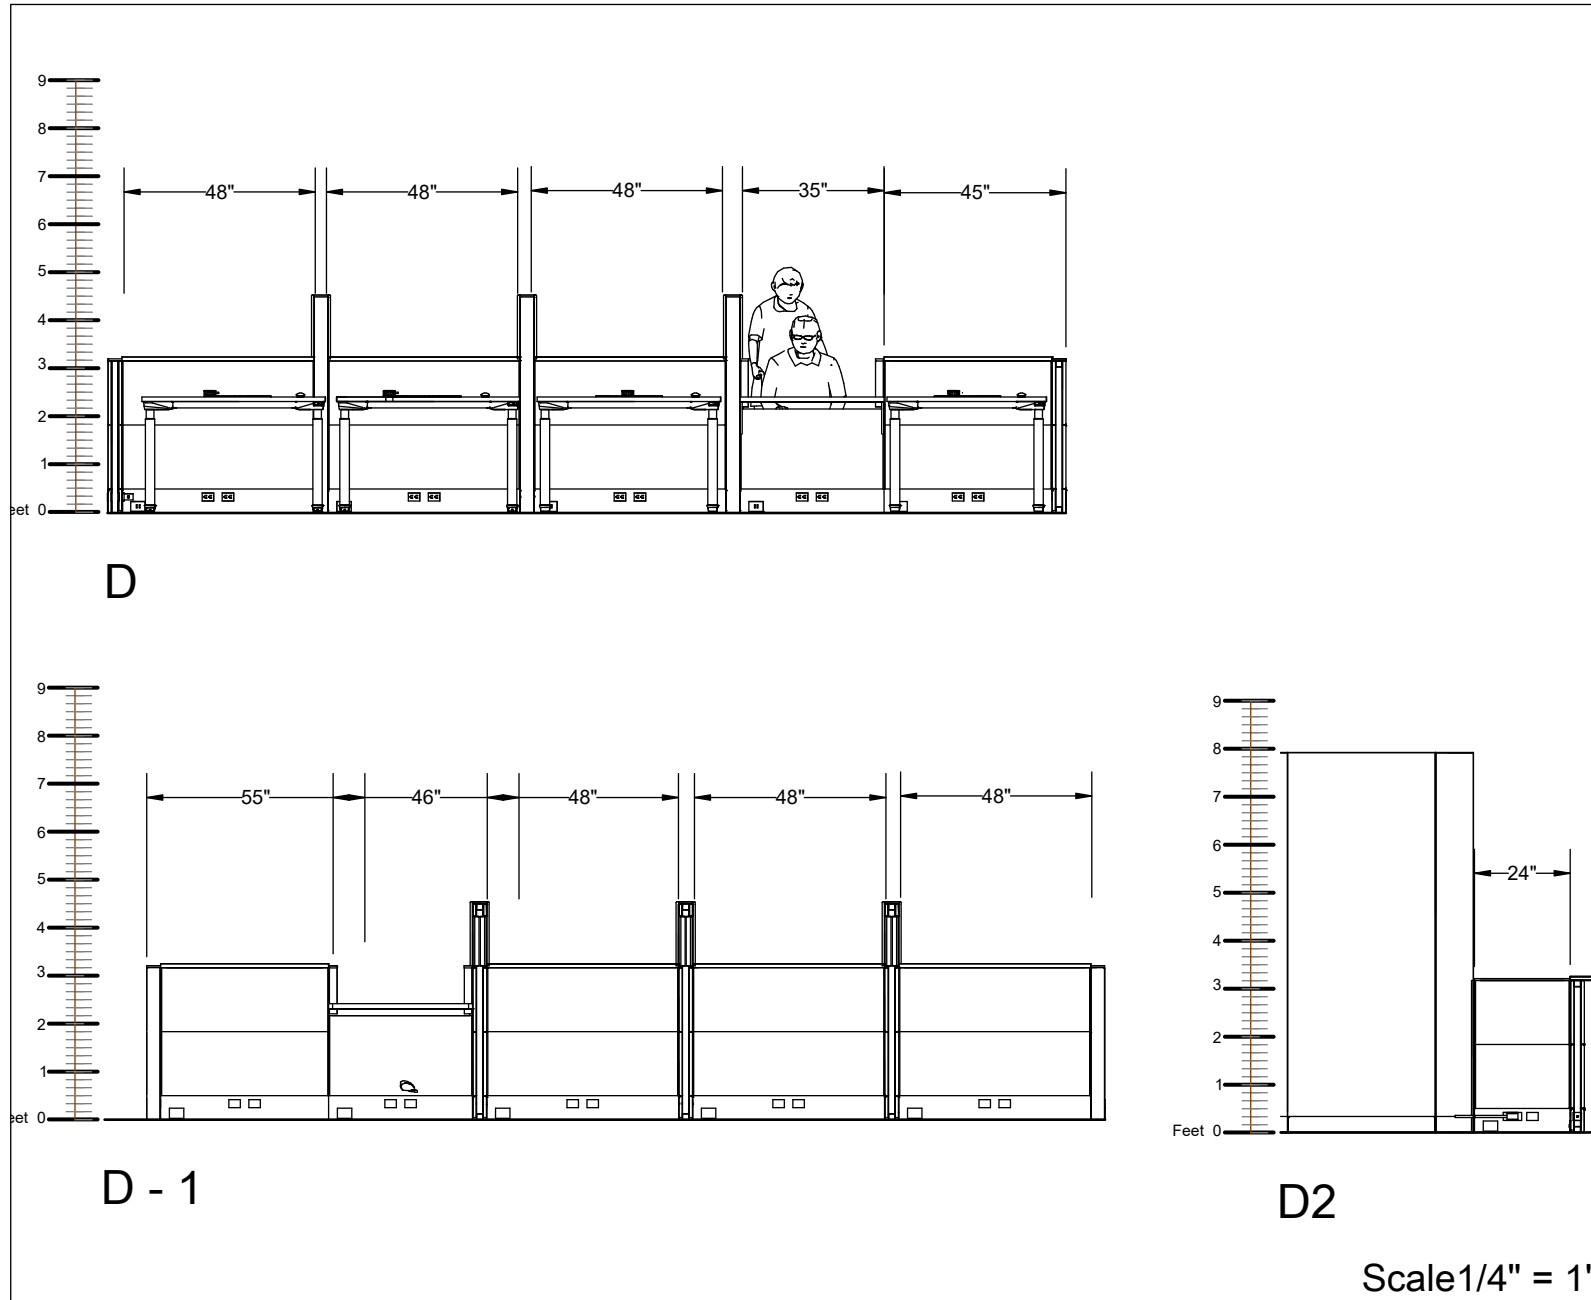


CLINIC MOD REC 222

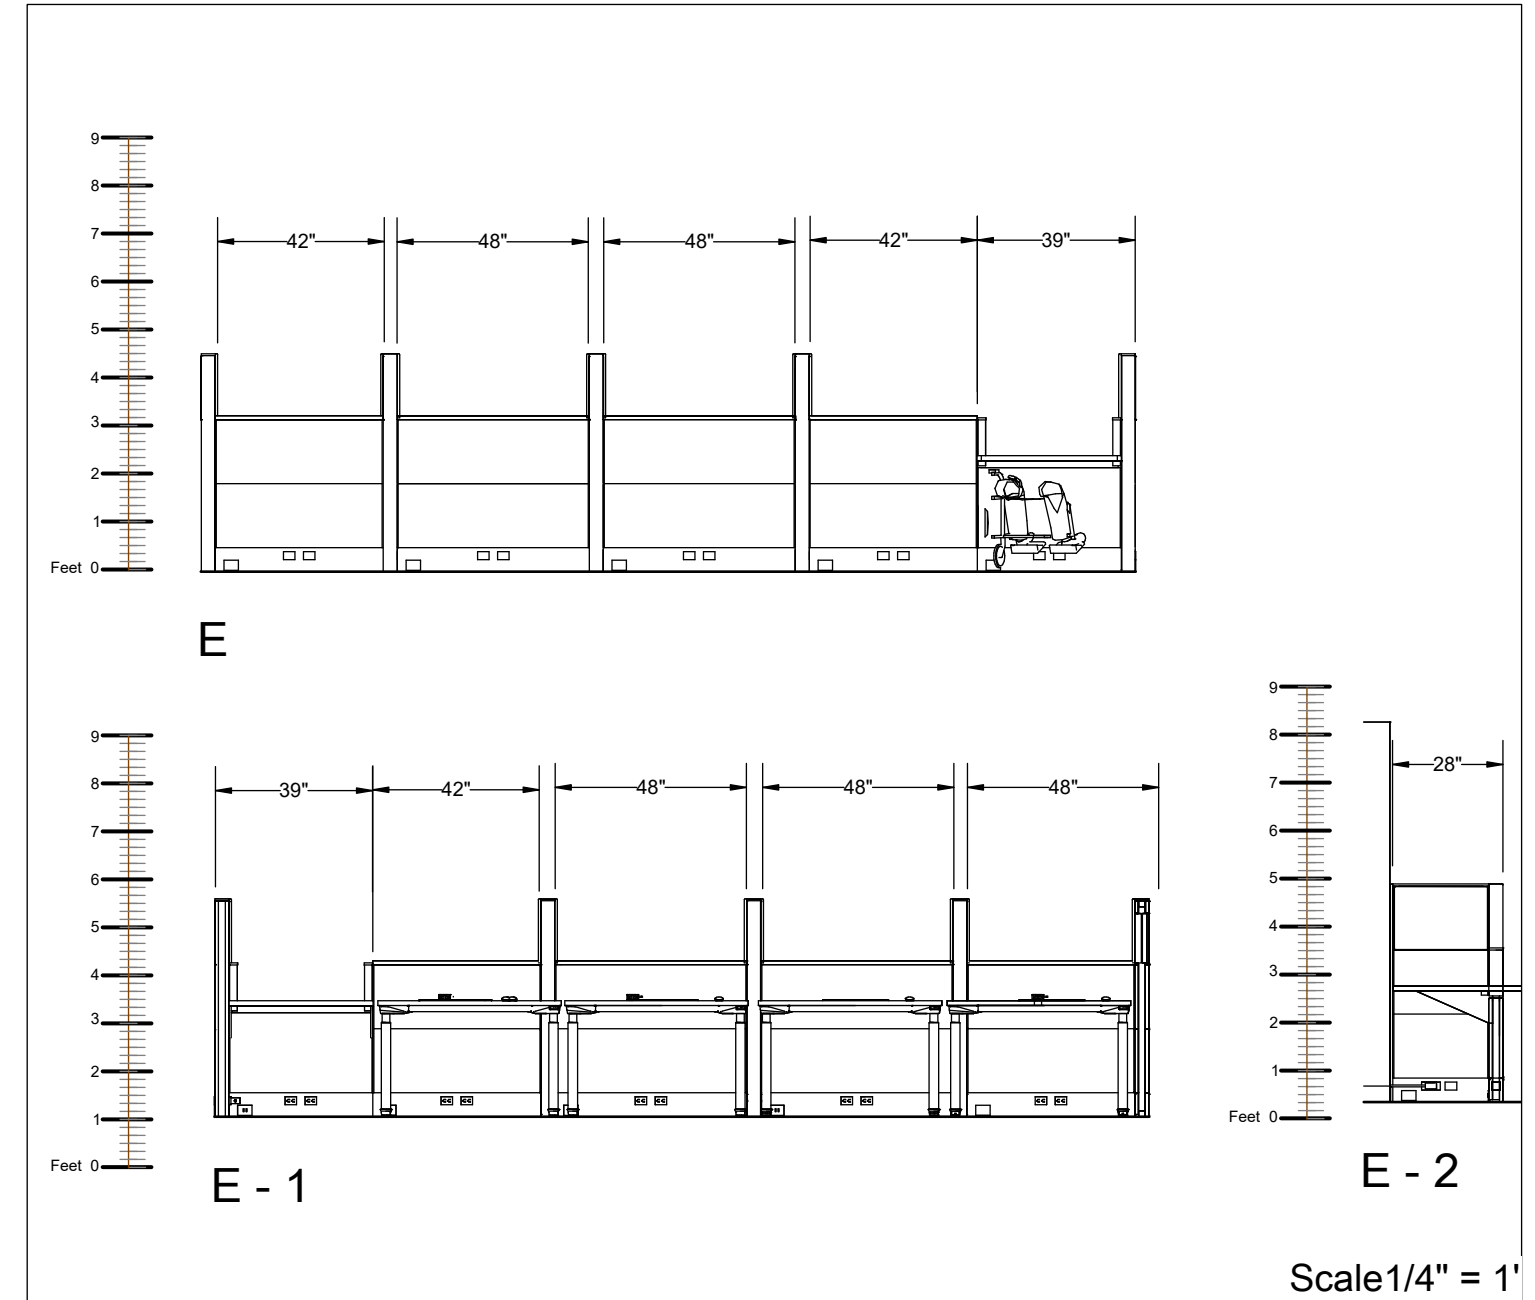

CLINIC MOD REC 149

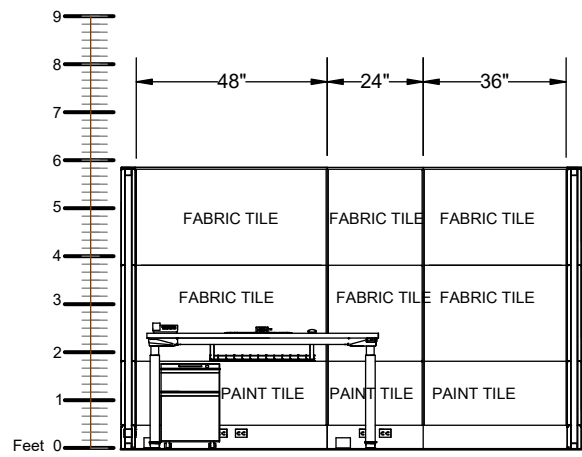


F

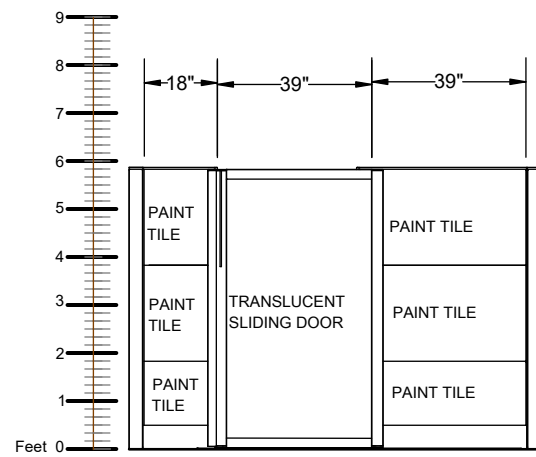


F - 1

Scale 1/4" = 1'


CBOC AREA 225

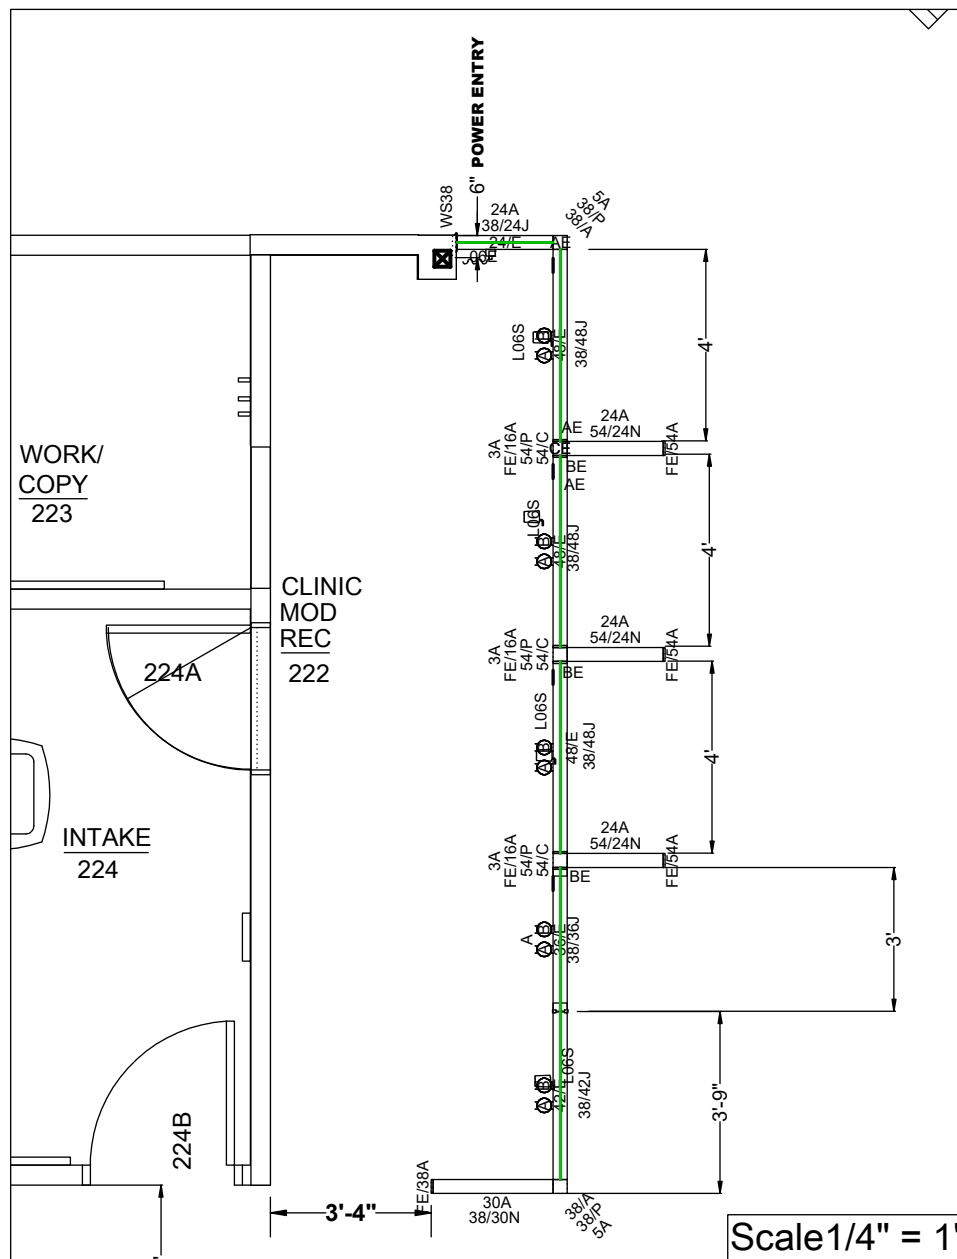


ELECTRICAL PLAN
CLINIC MOD REC 222

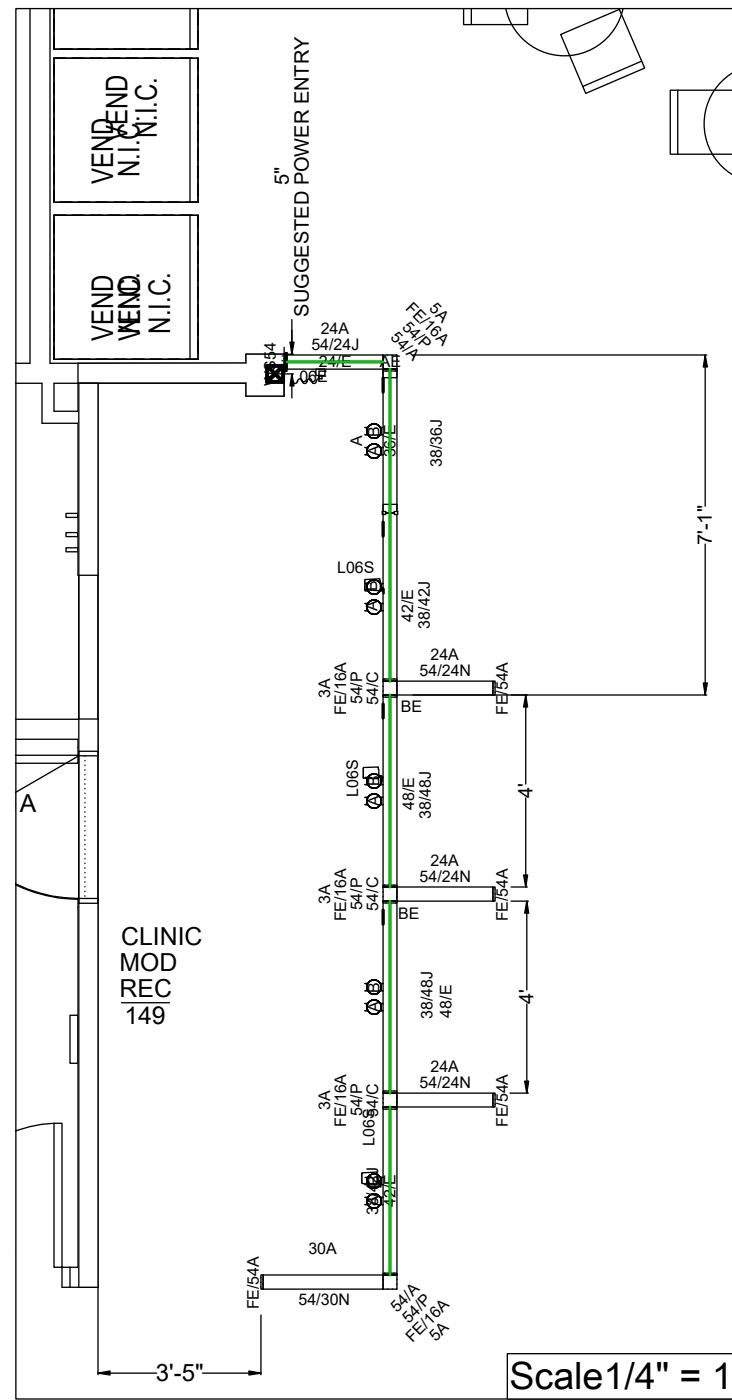

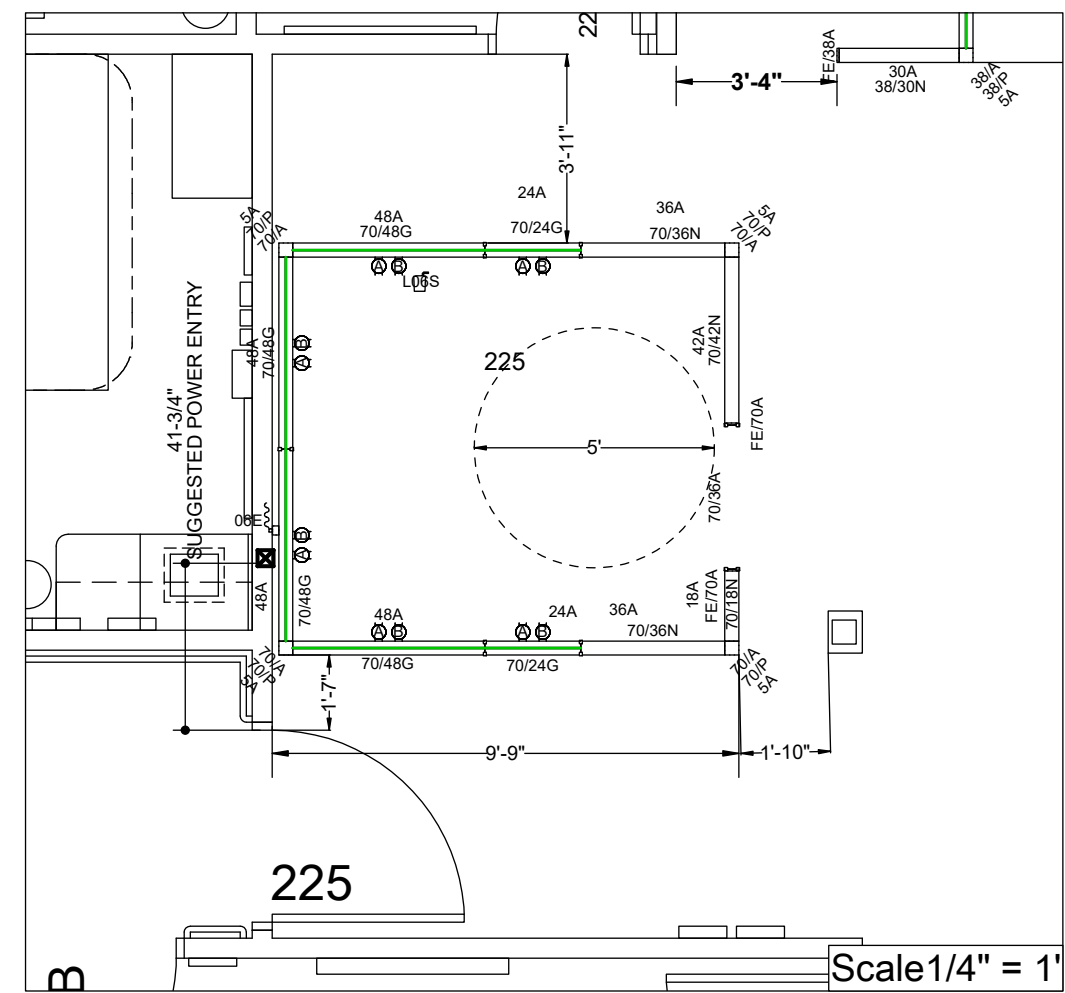



ELECTRICAL PLAN
CLINIC MOD REC 149

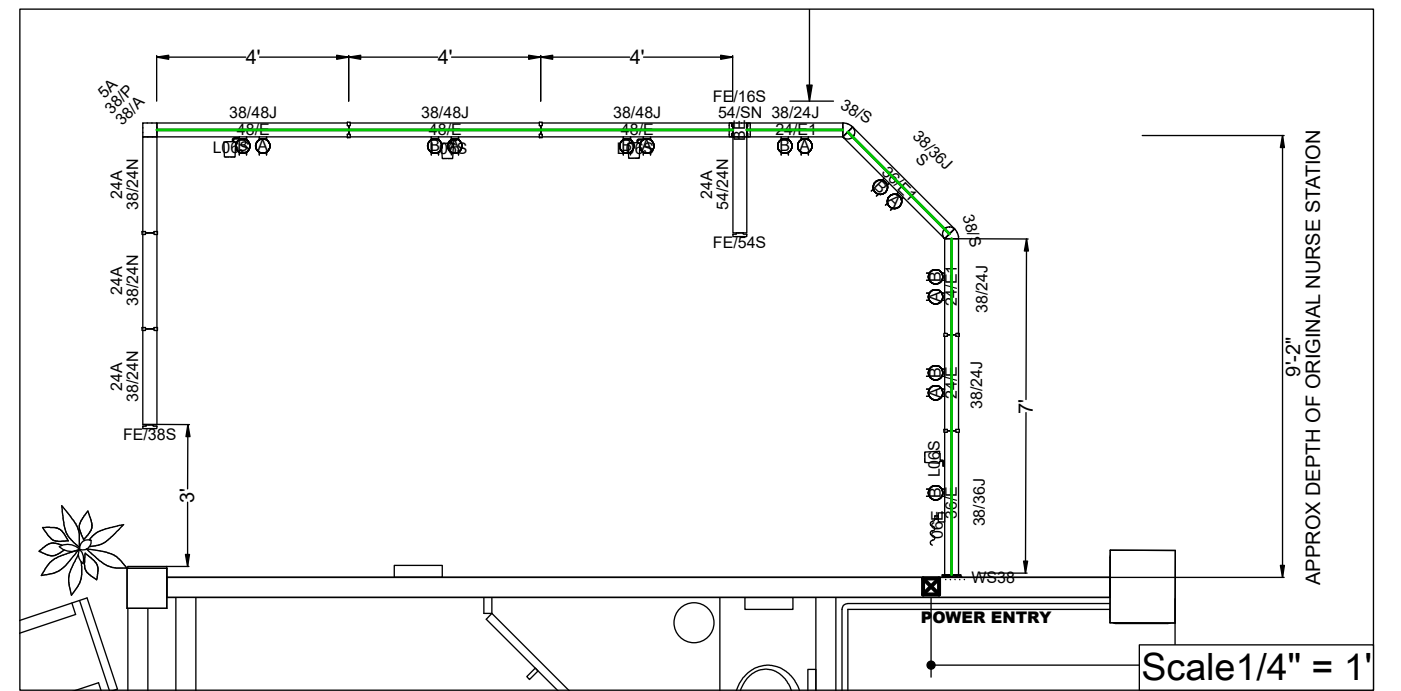


ELECTRICAL PLAN
CBOC AREA 225

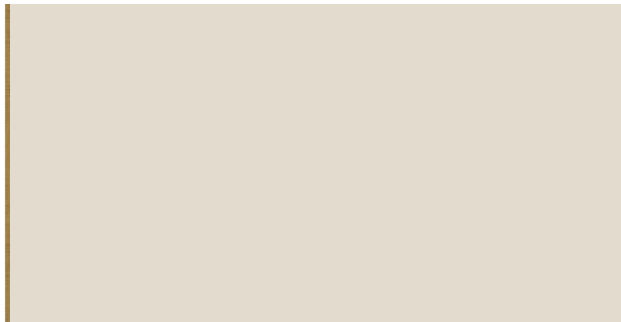

ELECTRICAL PLAN
REGISTRATION 102

| | | | | |
|---|--|--|--|--|
|  |  |  |  | |
| <p>MILLER KNOLL LU SOFT WHITE</p> <p>All trim, base, files and supports</p> | <p>MILLER KNOLL Laminate - LU Soft White</p> <p>Worksurfaces</p> | <p>MILLER KNOLL Corian GlacierWhite QC</p> <p>RECEPTION TRANSACTION TOPS</p> | <p>MILLER KNOLL HORIZON RYE GRASS: 4N01</p> <p>INTERIOR PANEL FABRIC</p> | <p>MILLER KNOLL DuraWrap TILE LBU - Medium Matte Walnut</p> <p>Exterior tiles Credenza</p> |

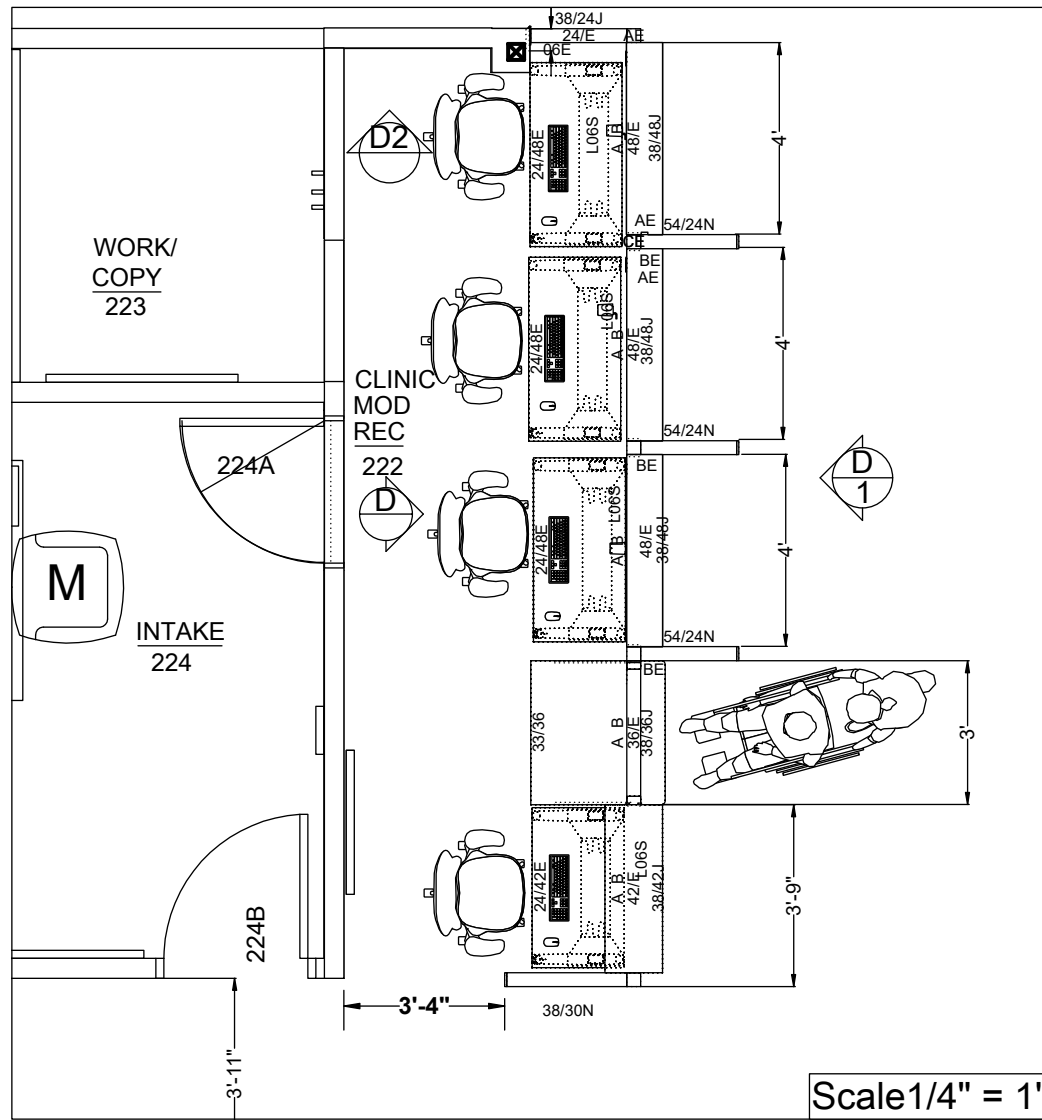

MILLER KNOLL
-ETHOSPACE
NOTE: ELECTRICAL
-"QUICK CONNECT"

POWER ENTRY AT WALL

A LISCENSED
ELECTRICIAN REQUIRED
TO CONNECT WHIP TO
POWER SCOURCE



CLINIC MOD REC 222 (North Desk)


A. ADA ACCESS 36" WIDE


B. 24 X 48 WIDE HEIGHT ADJ. TABLES
LOGIC TECH USB/ELEC OUTLET.

C. 24 X 42 WIDE HEIGHT ADJ. TABLES
LOGIC TECH USB/ELEC OUTLET.

D. DURAWRAP TILE - FINISH LBU

E. MIRRA TASK CHAIR

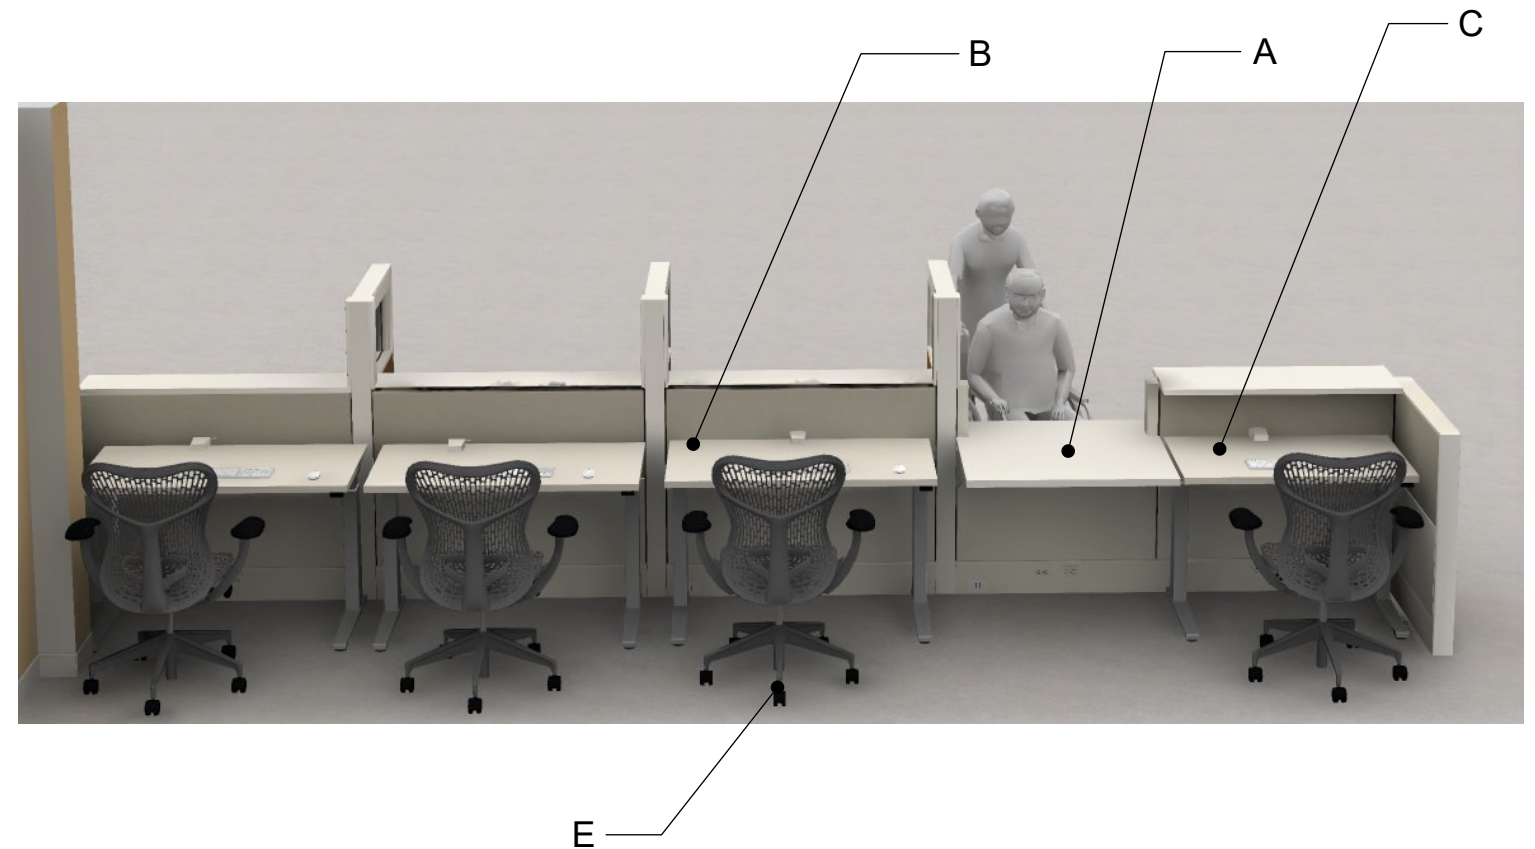


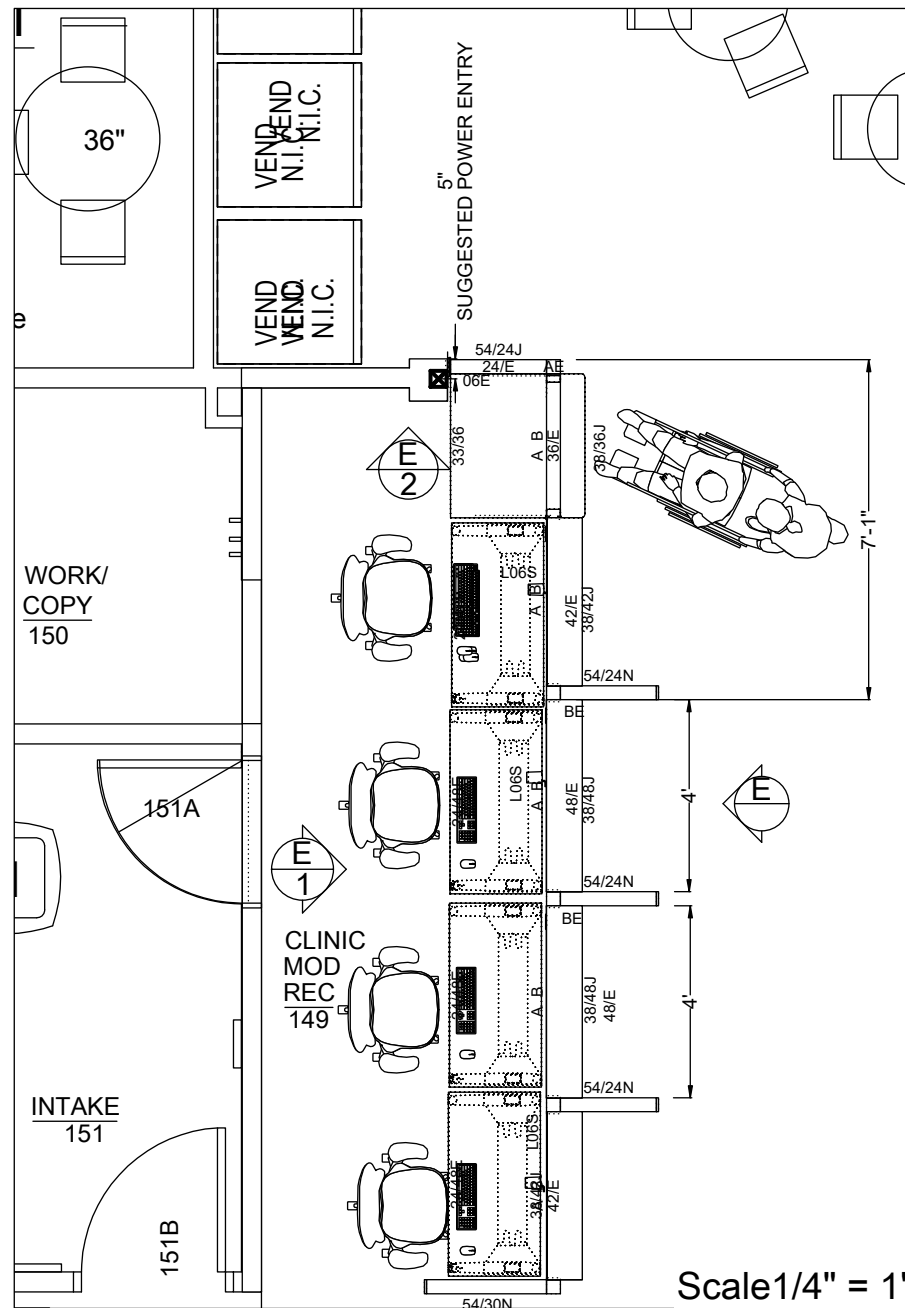


MILLER KNOLL -ETHOSPACE
 NOTE: ELECTRICAL -"QUICK
 CONNECT"
 POWER ENTRY AT WALL .
 A LISCENCED ELECTRICIAN
 REQUIRED TO CONNECT WHIP
 TO POWER SCOURCE

CLINIC MOD REC 149 (South Desk)

- A. ADA ACCESS 36" WIDE
- B. 24 X 48 WIDE HEIGHT ADJ. TABLES
- C. LOGIC TECH USB/ELEC OUTLET.
- D. DURAWRAP TILE - FINISH LBU
- E. MIRRA TASK CHAIR

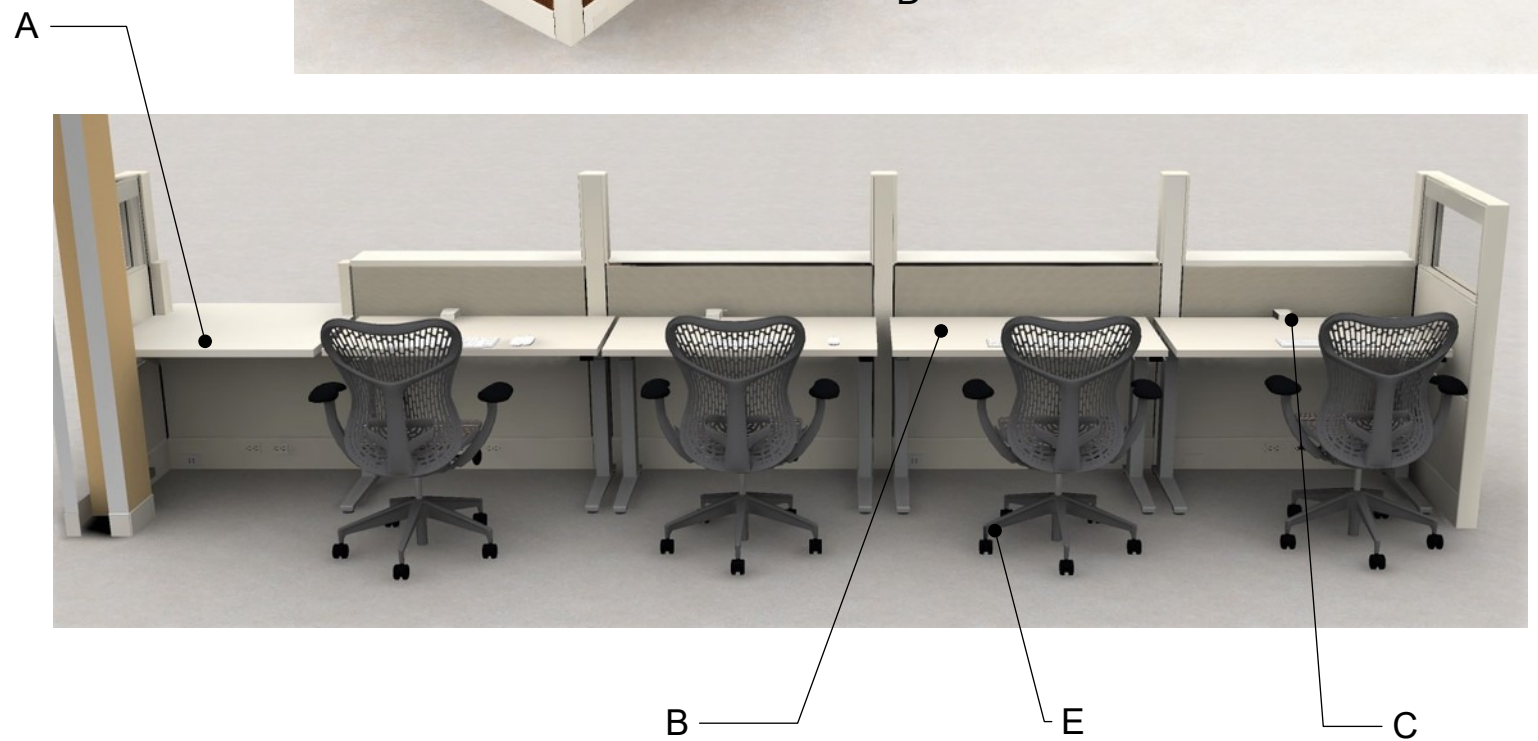

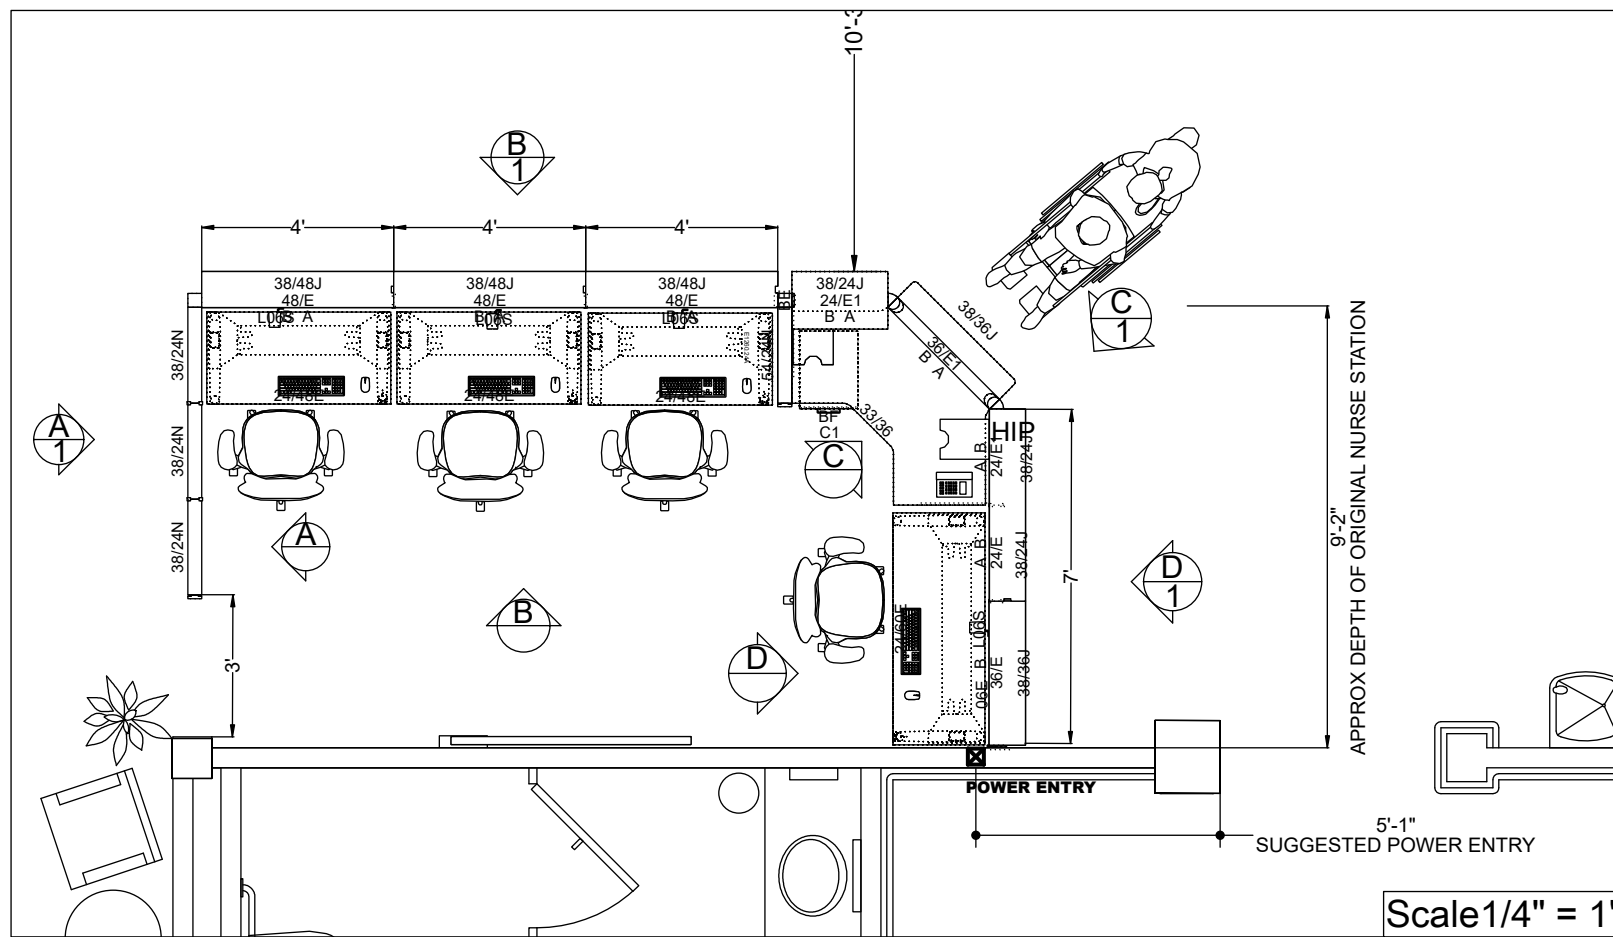

MILLER KNOLL -ETHOSPACE
 NOTE: ELECTRICAL -"QUICK CONNECT"

POWER ENTRY AT WALL .
 A LISCENSED ELECTRICIAN REQUIRED
 TO CONNECT WHIP TO POWER
 SCOURCE

REGISTRATION 102

A. ADA ACCESS 135 DEGREE

B. 24 X 48 WIDE HEIGHT ADJ. TABLES

C. LOGIC TECH USB/ELEC OUTLET.

D. DURAWRAP TILE - FINISH LBU


E. MIRRA TASK CHAIR

F. MOBILE BF WITH CUSHION TOP- FABRIC TO BE
 CONFIRMED


G. PAPER MGT FOR FORMS



A D

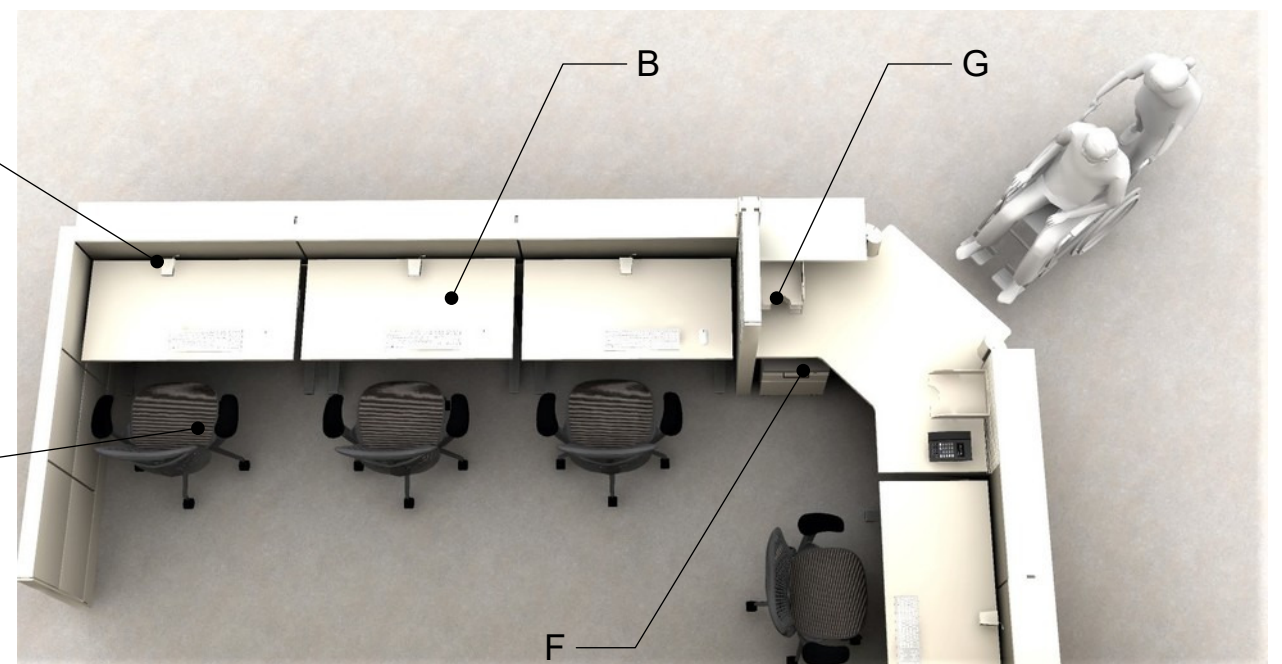


B C E F G

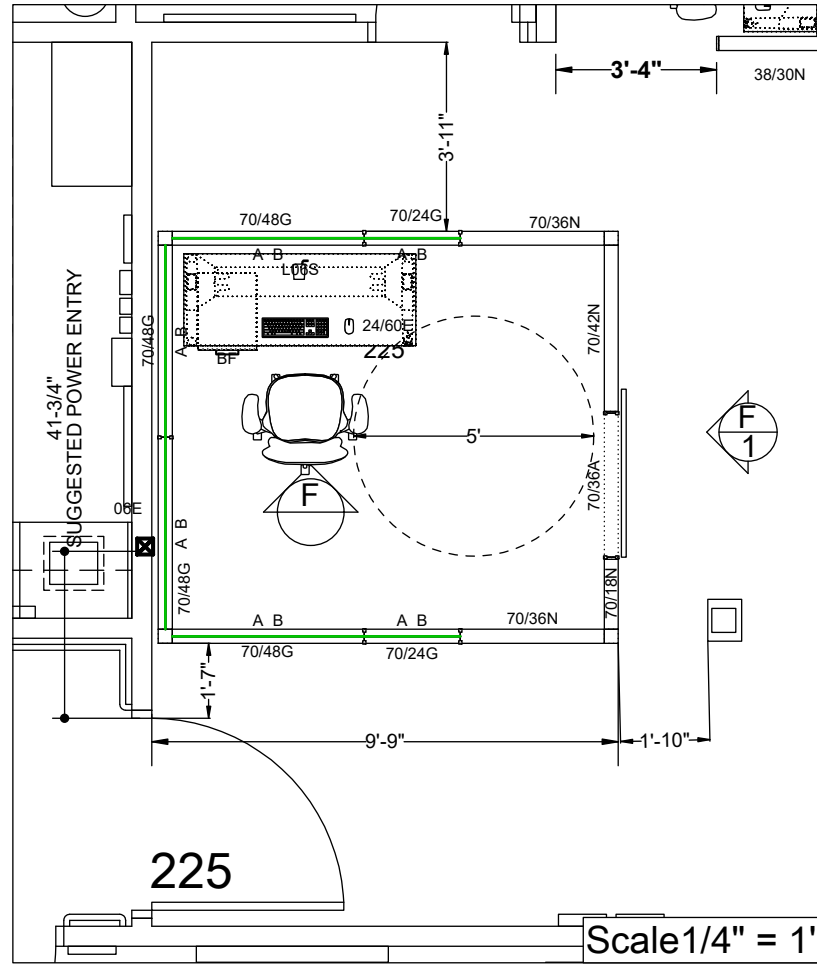

NOTE:
ADDITIONAL EXISTING WAIT ROOM
CHAIRS MAY NEED TO BE MOVED
TO ANOTHER LOCATION

MILLER KNOLL - ETHOSPACE
ALL EXTERIOR PANELS
TO BE PAINTED TILES

NOTE: ELECTRICAL - QUICK CONNECT
POWER ENTRY AT WALL .
A LISCENSED ELECTRICIAN REQUIRED TO
CONNECT WHIP.

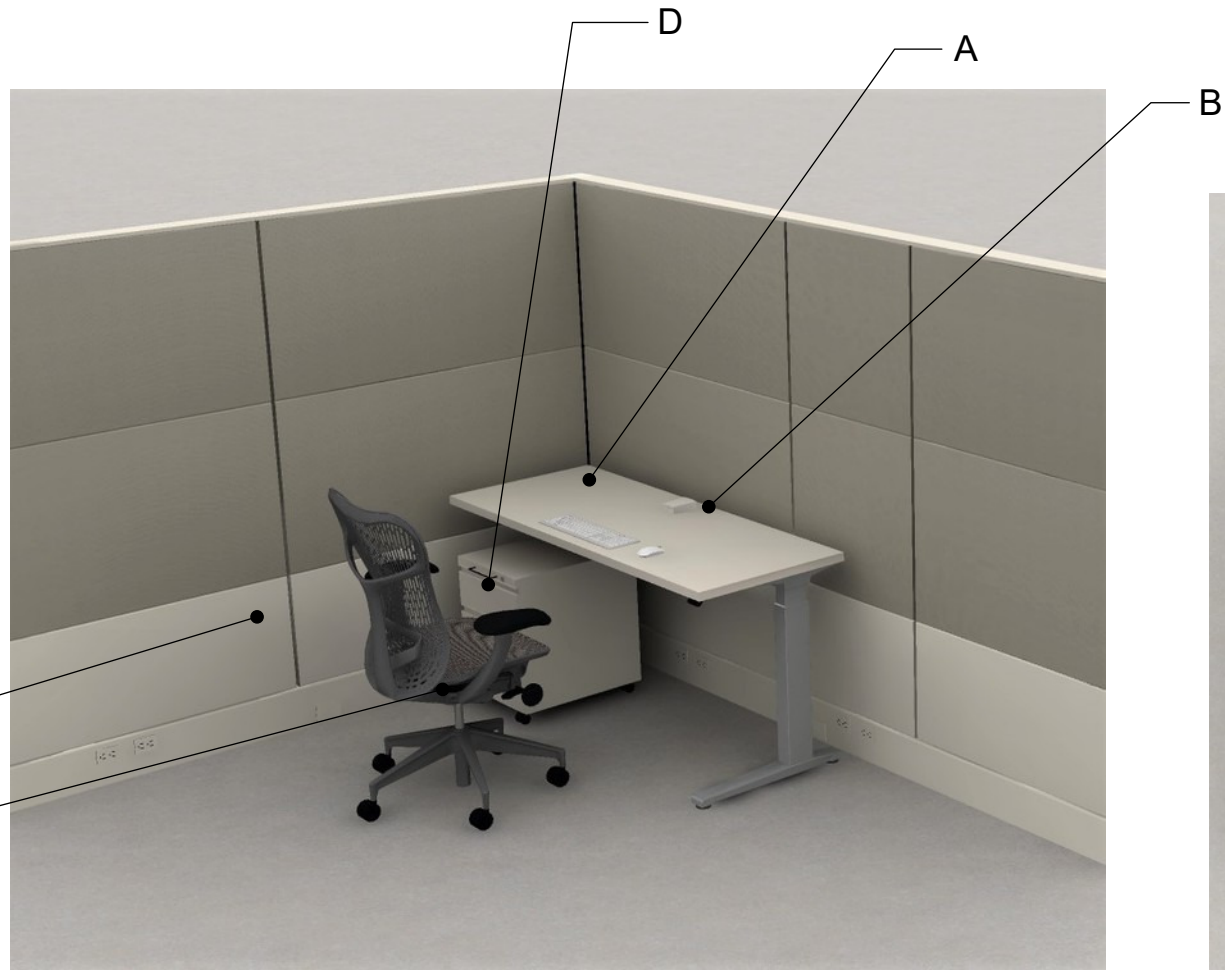

CBOC AREA 225 (Consult Cubicle)

A - 24 X 60 HEIGHT
ADJUSTABLE DESK

B - HMI LOGIC TECH WITH 6'
CORD

C - MIRRA TASK CHAIR

D - BF MOBILE PED 20" DEEP

E - INTERIOR PERIMETER
BOTTOM PANELS TO BE
PAINTED TILE

FROSTED GLASS SLIDING
DOOR